


Handwritten signature

FLOOR PLAN
SCALE: 1/4" = 1'-0"

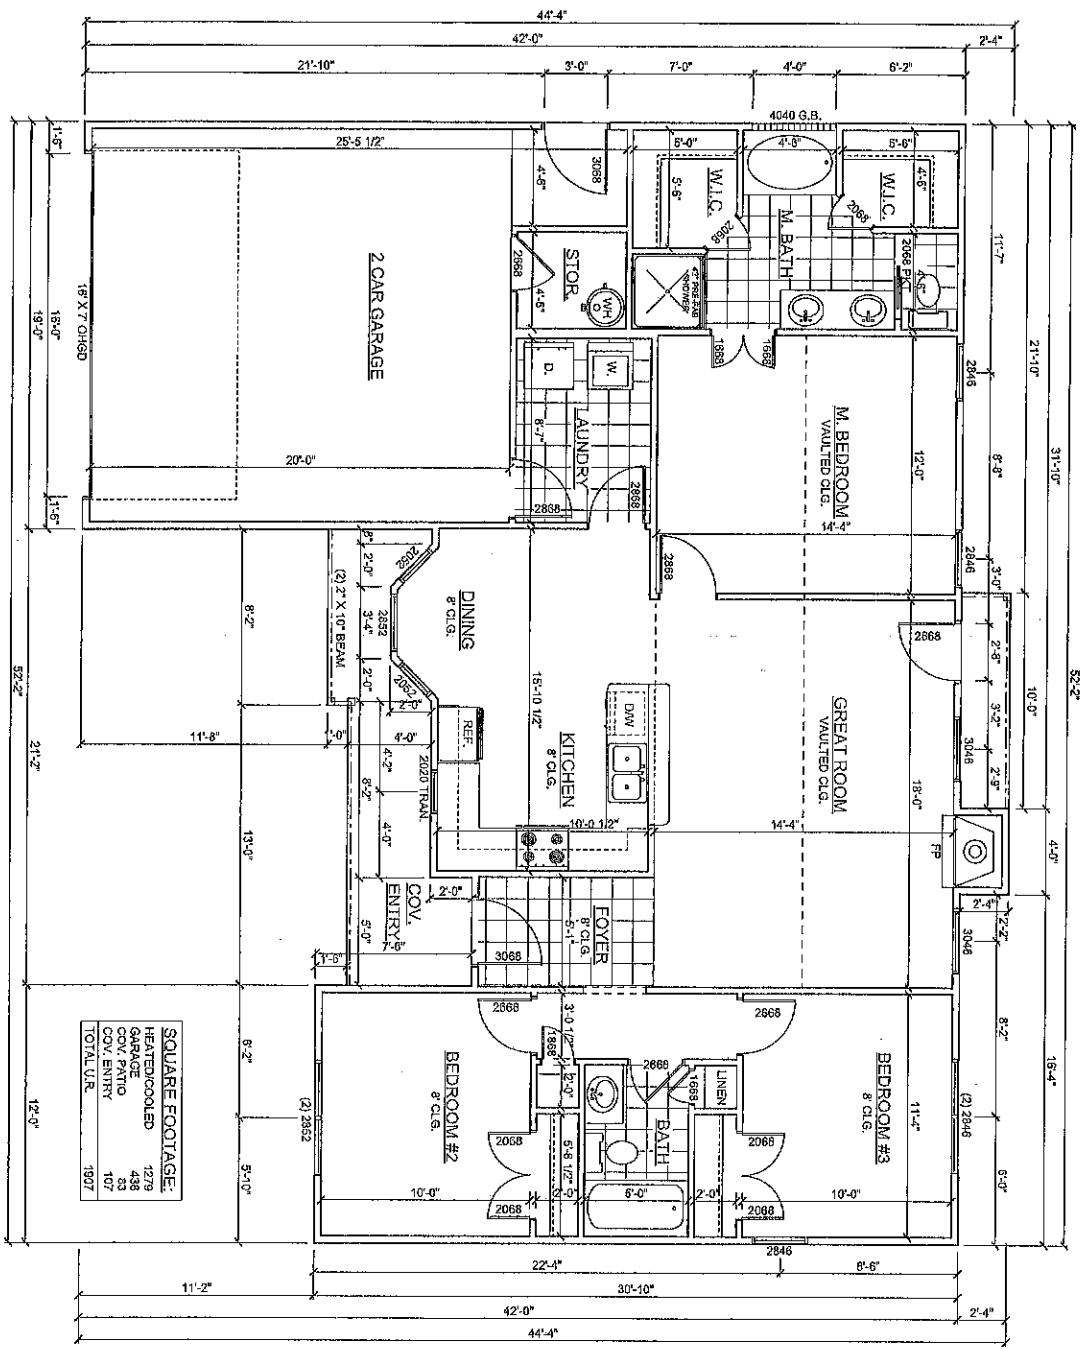

1 OF 6
SHEET NUMBER

DATE: 03/01/2011
DRAWN: KD
CHECKED:
REVISIONS:



A PROPOSED RESIDENCE FOR:
CHESTNUT MODEL
LOT 25 - PALO ALTO

FIRST PRIORITY CONSTRUCTION
GREENVILLE, NC
(252) 714-5891


VISUAL CONCEPTS
DRAWING & DESIGN
(828) 649-7038

TYPICAL WALL SECTION
EXTERIOR FRAME

SCALE 3/4" = 1'-0"
9
S6

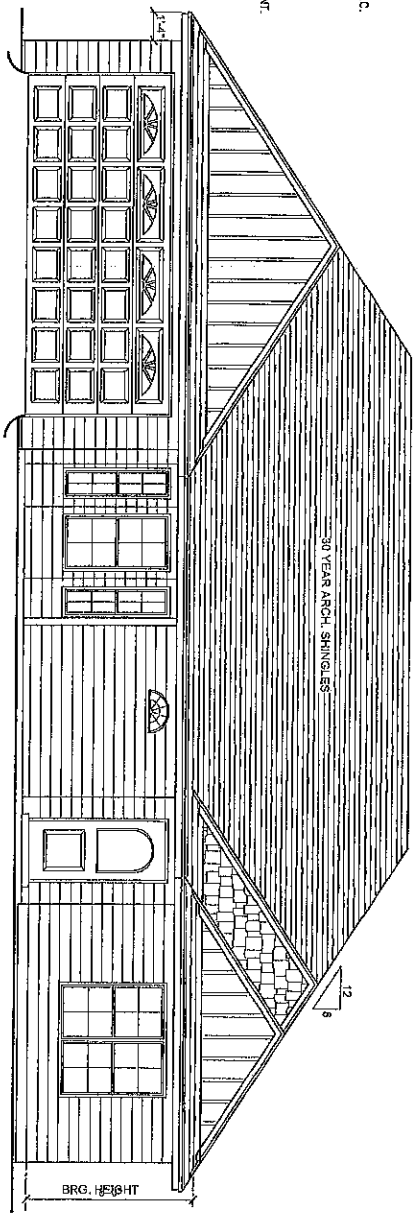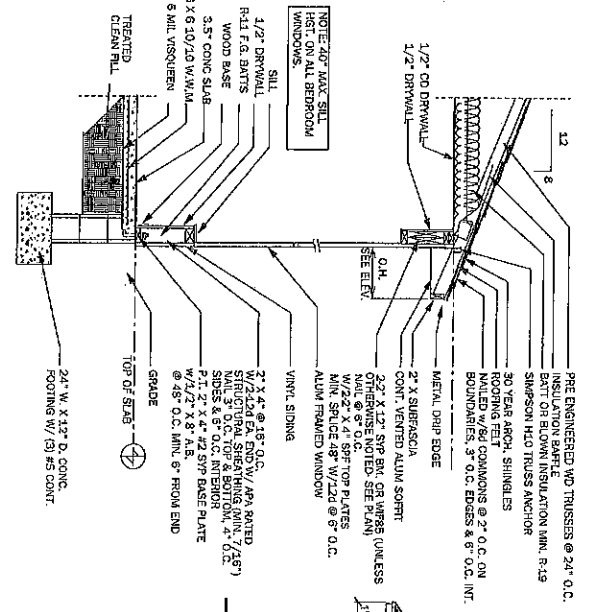


FRONT ELEVATION
SCALE 1/4" = 1'-0"

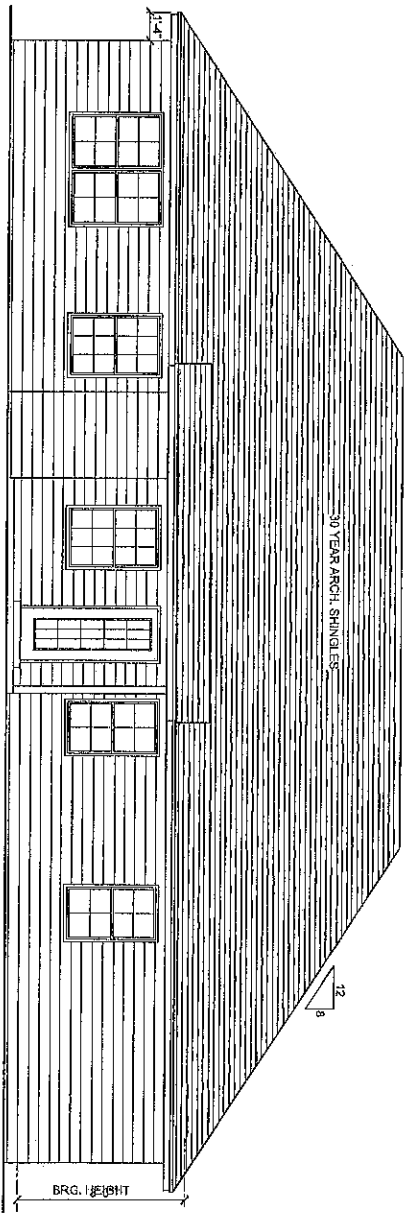


REAR ELEVATION
SCALE 1/4" = 1'-0"

<p>2 OF 6</p>	DATE: 03/01/2011	A PROPOSED RESIDENCE FOR:	<p>FIRST PRIORITY CONSTRUCTION</p> <p>GREENVILLE, NC</p> <p>(252) 714-5891</p>	<p>VISUAL CONCEPTS</p> <p>DRAFTING & DESIGN</p> <p>(828) 640-7078</p>
	DRAWN: KD	<u>CHESTNUT MODEL</u>		
	CHECKED:	LOT 25 - PALO ALTO		
	REVISIONS:			

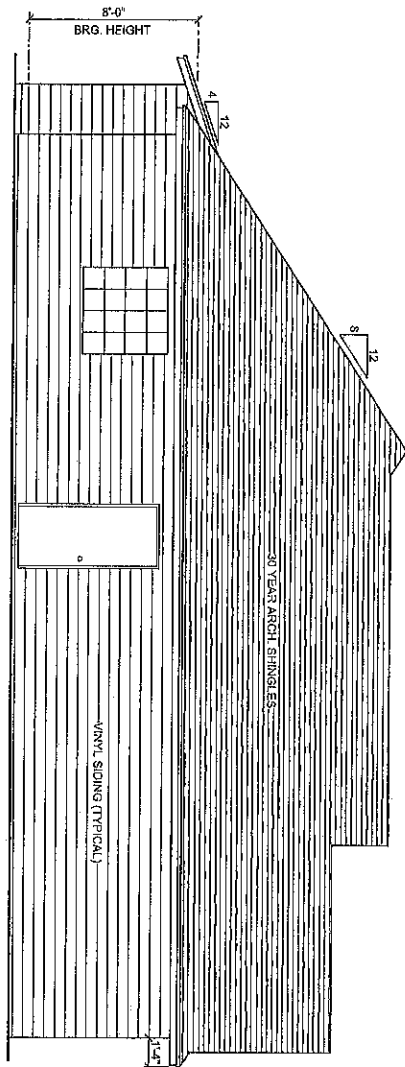

LEFT SIDE ELEVATION

SCALE: 1/4" = 1'-0"

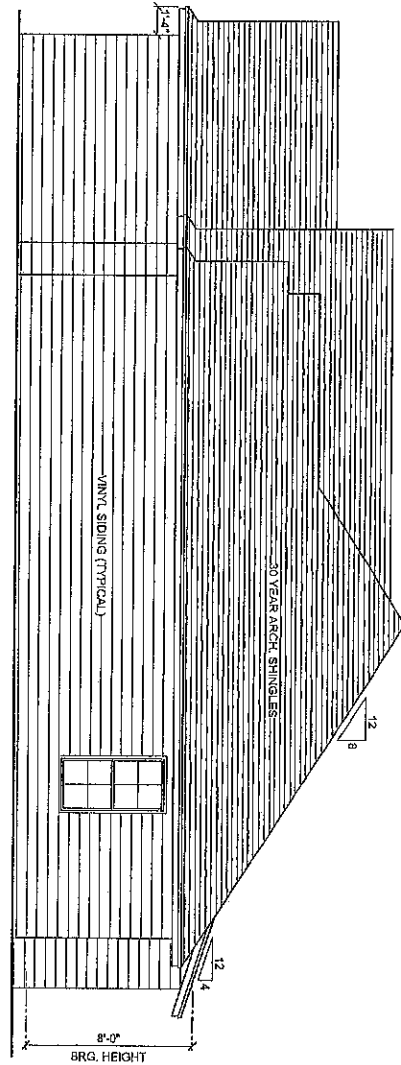

RIGHT SIDE ELEVATION

SCALE: 1/4" = 1'-0"

3 OF 3


PROJECT #1103

DATE: 03/01/2011
 DRAWN: KD
 CHECKED:
 REVISIONS:

A PROPOSED RESIDENCE FOR:
CHESTNUT MODEL
 LOT 25 - PALO ALTO

FIRST PRIORITY CONSTRUCTION
 GREENVILLE, NC (252) 714-5891

VISUAL CONCEPTS
 DRAFTING & DESIGN
 (252) 549-7338

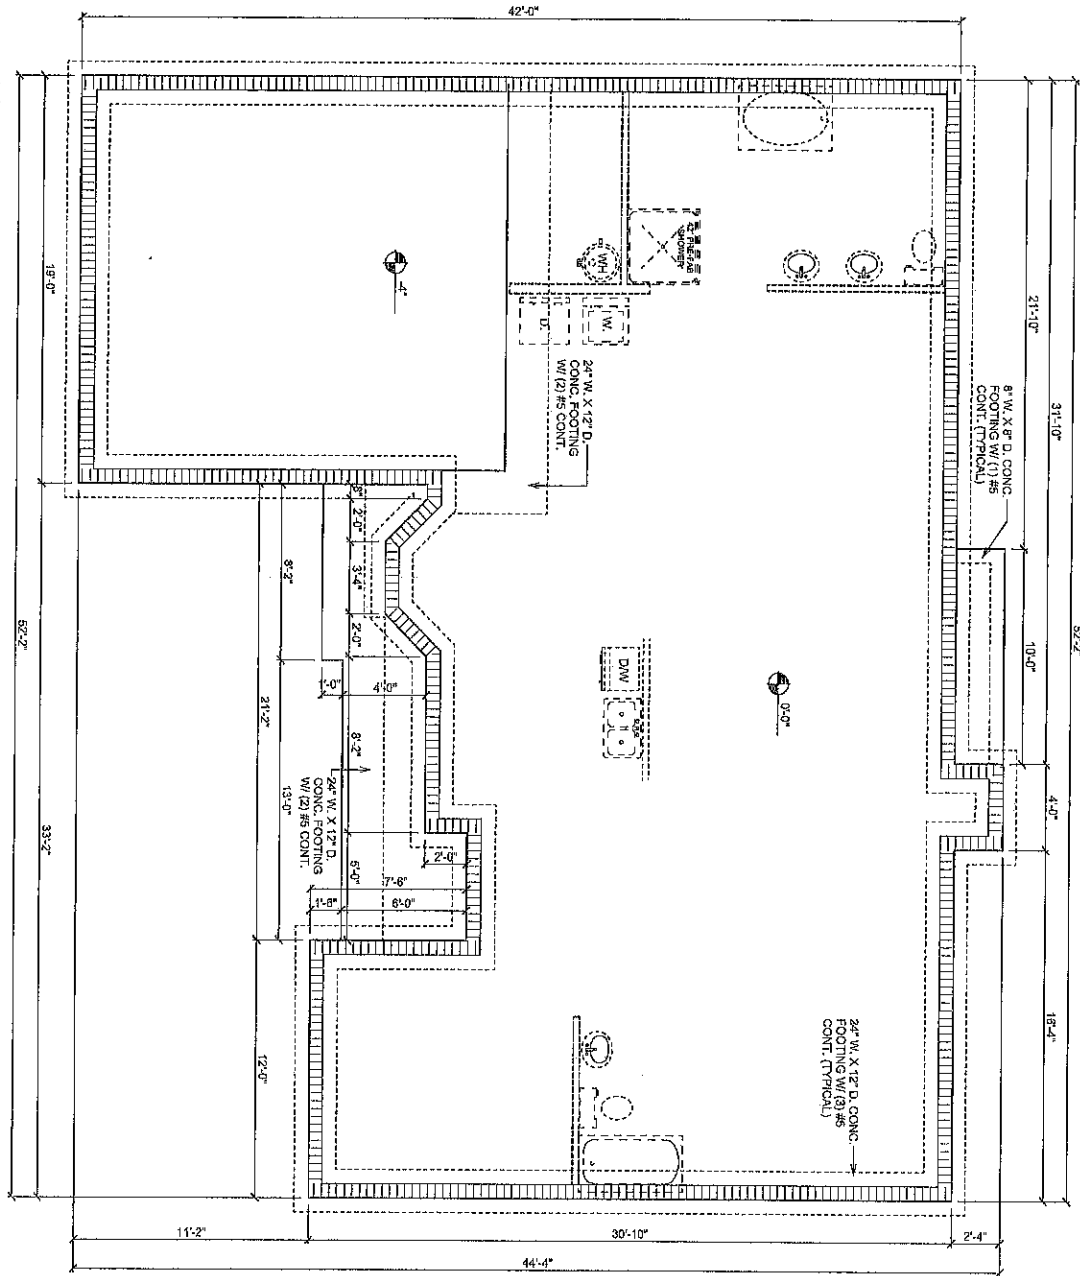

FOUNDATION PLAN
SCALE: 1/4" = 1'-0"


DATE: 03/01/2011
DRAWN: KD
CHECKED:
REVISIONS:

A PROPOSED RESIDENCE FOR:
CHESTNUT MODEL
LOT 25 - PALO ALTO

FIRST PRIORITY CONSTRUCTION
GREENVILLE, NC
(252) 714-5891

VISUAL CONCEPTS
DRAFTING & DESIGN
(924) 649-7028

ROOF PLAN
SCALE: 1/4" = 1'-0"

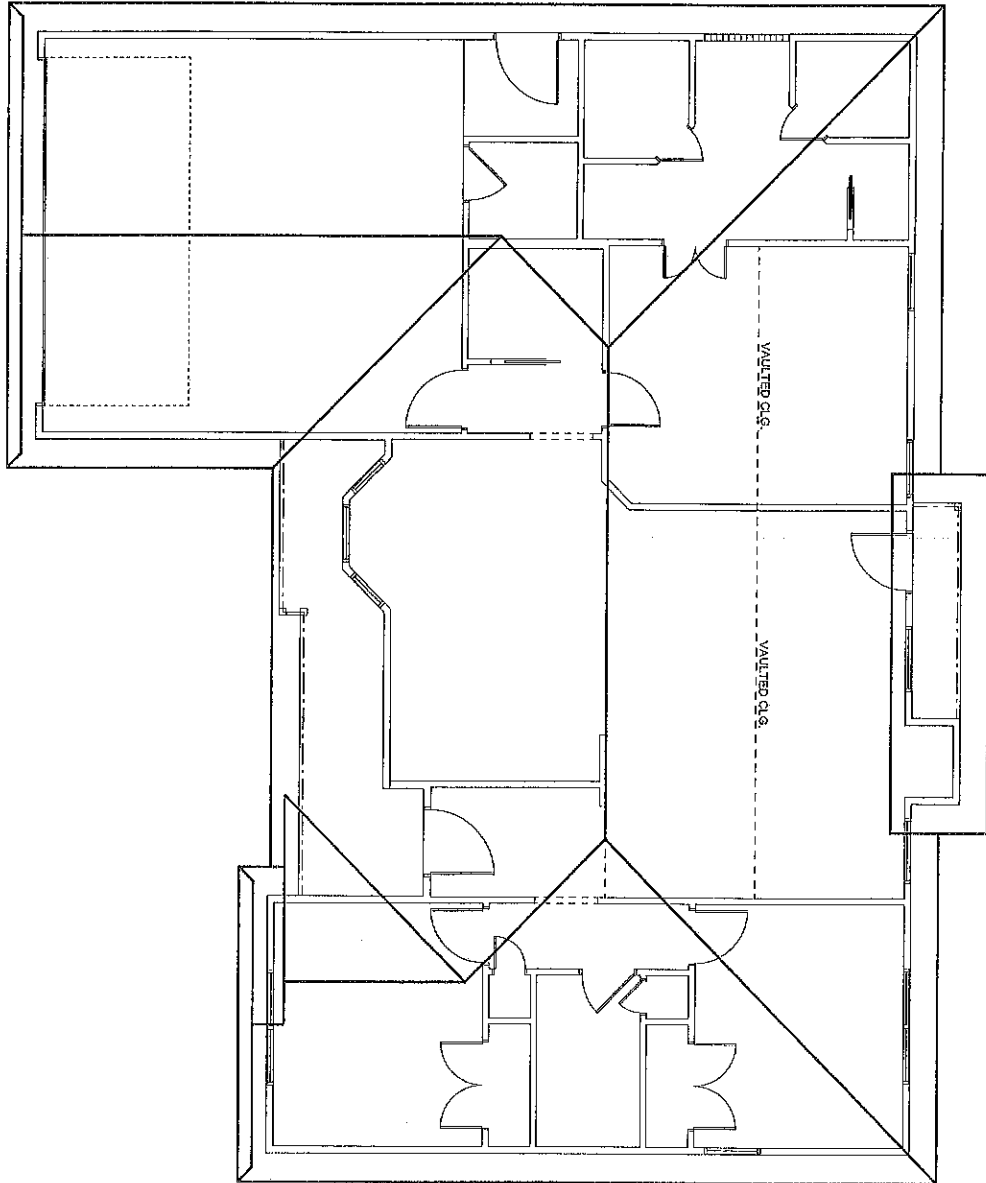

- NOTES:**
1. UNLESS OTHERWISE NOTED
 2. ELECTRICAL PLAN IS INTENDED FOR BID PURPOSES ONLY. ALL WORK SHALL BE IN ACCORDANCE WITH THE NATIONAL ELECTRICAL CODE, LATEST EDITION, BY THE NATIONAL FIRE ALARMING ASSOCIATION, INC. FOR THE INSTALLATION & SIZING OF ALL ELECTRICAL WIRING & ACCESSORIES.
 3. SMOKE DETECTORS SHALL BE INSTALLED AS DIRECTED BY THE NATIONAL FIRE ALARMING ASSOCIATION, INC. PER SECTION 7603.4.2
 4. BATHROOM FANS TO BE VENTED THRU ROOF

ELECTRICAL LEGEND					
SYMBOL	DEFINITION	NOTES	SYMBOL	DEFINITION	NOTES
	110V OUTLET			EXHAUST FAN WITH LIGHT	
	110V OUTLET GROUND FAULT INTERRUPTER			FLUORESCENT FIXTURE	
	220V OUTLET			RECESS LIGHTING	
	EXTERIOR WATERPROOF OUTLET			PHONE	
	SWITCH			SMOKE DETECTOR	BATT. BACKUP W/ INTERWIRE CONNECTED
	CEILING FAN WITH LIGHT			AIR COND. DISCONNECT	
				METER	

ELECTRICAL PLAN
SCALE: 1/4" = 1'-0"

