



FLOOR PLAN
SCALE: 1/4" = 1'-0"

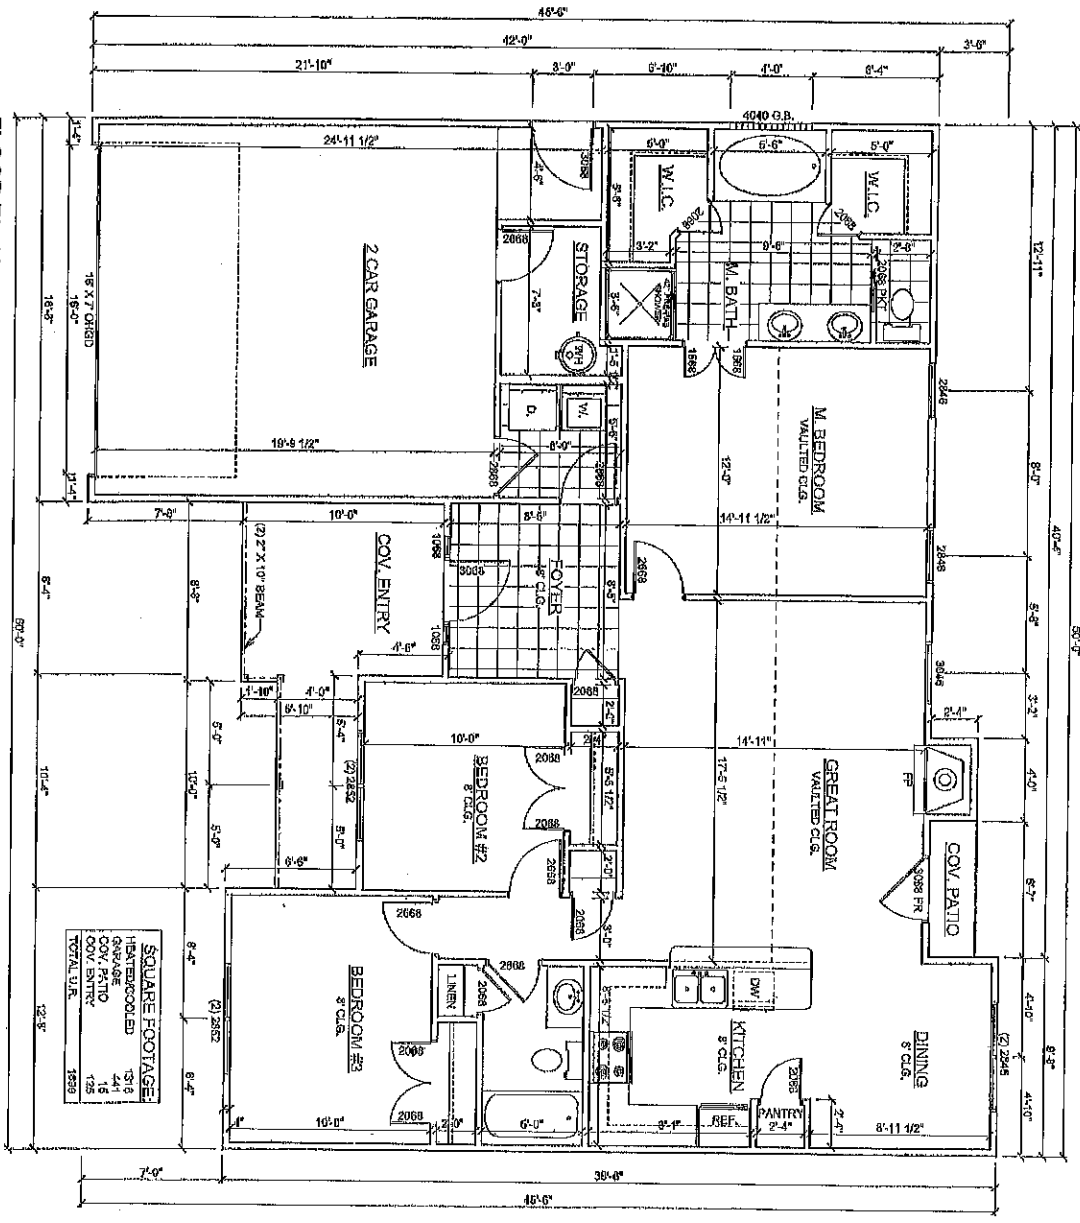


Handwritten signature and date: 8/9/12


<p>1 OF 6</p>	<p>DATE: 03/01/2011 DRAWN: KO CHECKED:</p>	<p>A PROPOSED RESIDENCE FOR: WILLOW MODEL LEFT HAND GARAGE</p>	<p>FIRST PRIORITY CONSTRUCTION GREENVILLE, NC (252) 714-5891</p>	<p>VISUAL CONCEPTS DRAWING & DESIGN R202/07-01/04/10/10/10</p>
	<p>PROJECT #1102 SHEET NUMBER</p>			

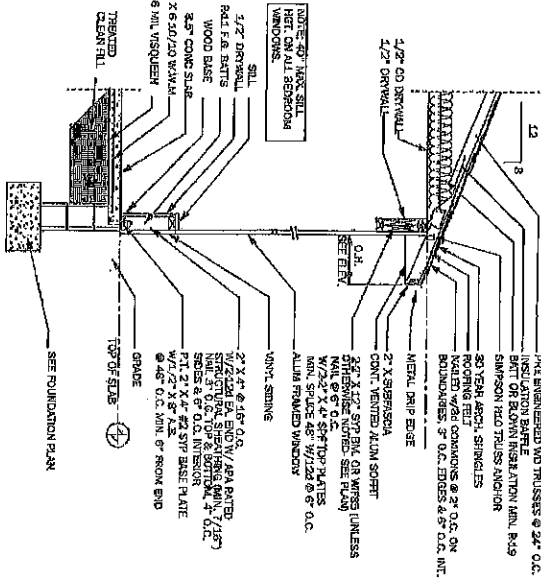

TYPICAL WALL SECTION
EXTERIOR FRAME
SCALE: 1/2" = 1'-0"
9
S6

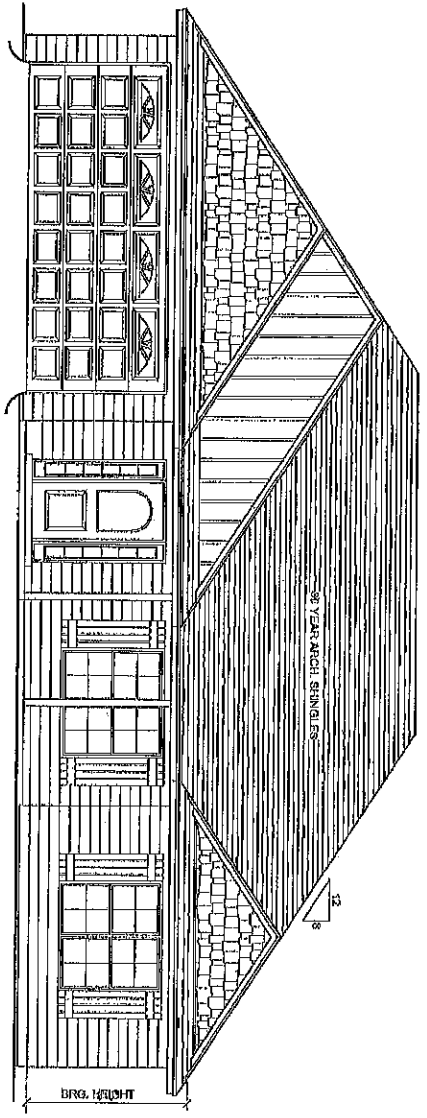


FRONT ELEVATION
SCALE: 1/4" = 1'-0"

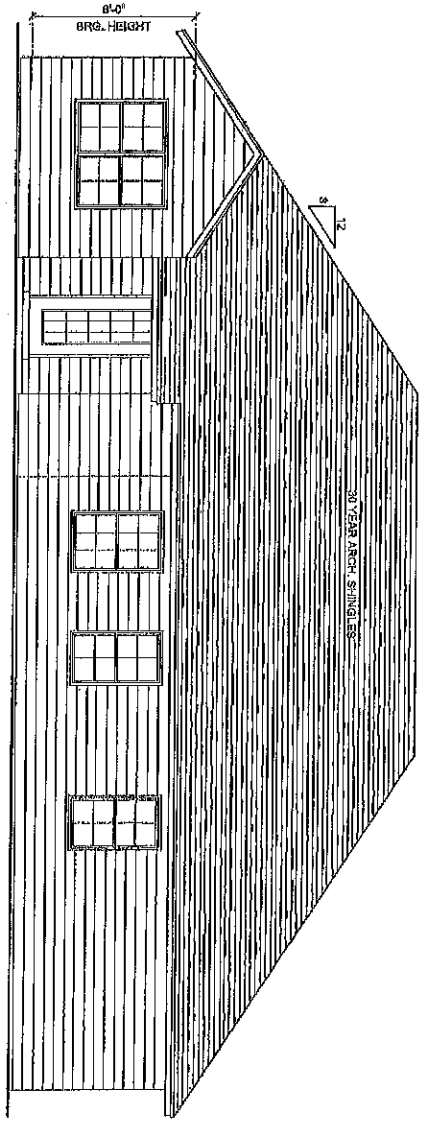


REAR ELEVATION
SCALE: 1/4" = 1'-0"

<p>2 OF 6</p>	<p>DATE: 03/01/2011 DRAWN: KD CHECKED:</p>	<p>A PROPOSED RESIDENCE FOR: WILLOW MODEL LEFT HAND GARAGE</p>	<p>FIRST PRIORITY CONSTRUCTION GREENVILLE, NC (252) 714-5891</p>	<p>VISUAL CONCEPTS DRAWING & DESIGN (828) 649-7036</p>
	<p>PROJECT: #1102 SHEET NUMBER:</p>	<p>REVISIONS:</p>		

LEFT SIDE ELEVATION
SCALE: 1/4" = 1'-0"

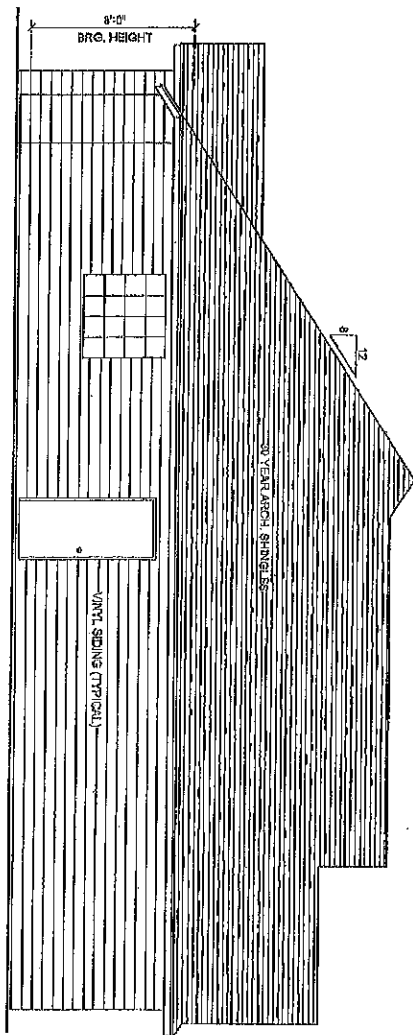

RIGHT SIDE ELEVATION
SCALE: 1/4" = 1'-0"

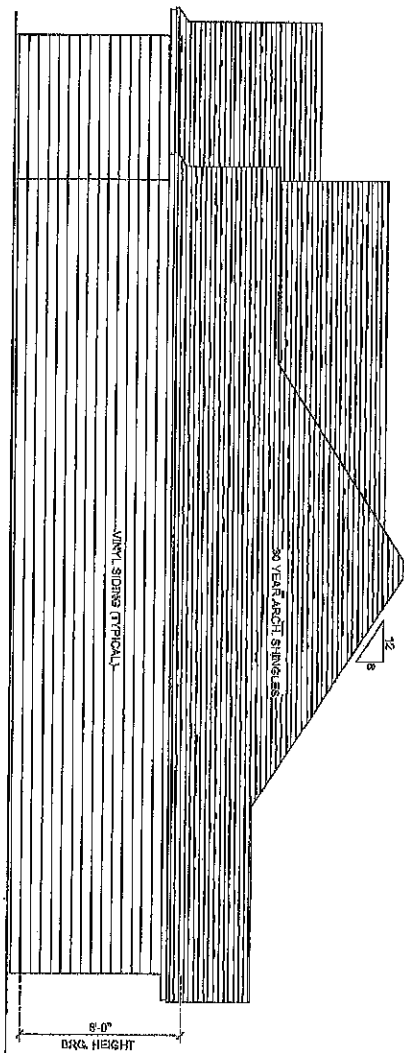

3 OF 6

PROJECT #1102


DATE: 03/01/2011
DRAWN: KD
CHECKED:
REVISIONS:

A PROPOSED RESIDENCE FOR:
WILLOW MODEL
LEFT HAND GARAGE


FIRST PRIORITY CONSTRUCTION
GREENVILLE, NC
(252) 714-5891

VISUAL CONCEPTS
DRAWING & DESIGN
(252) 614-7050

FOUNDATION PLAN
SCALE 1/8" = 1'-0"

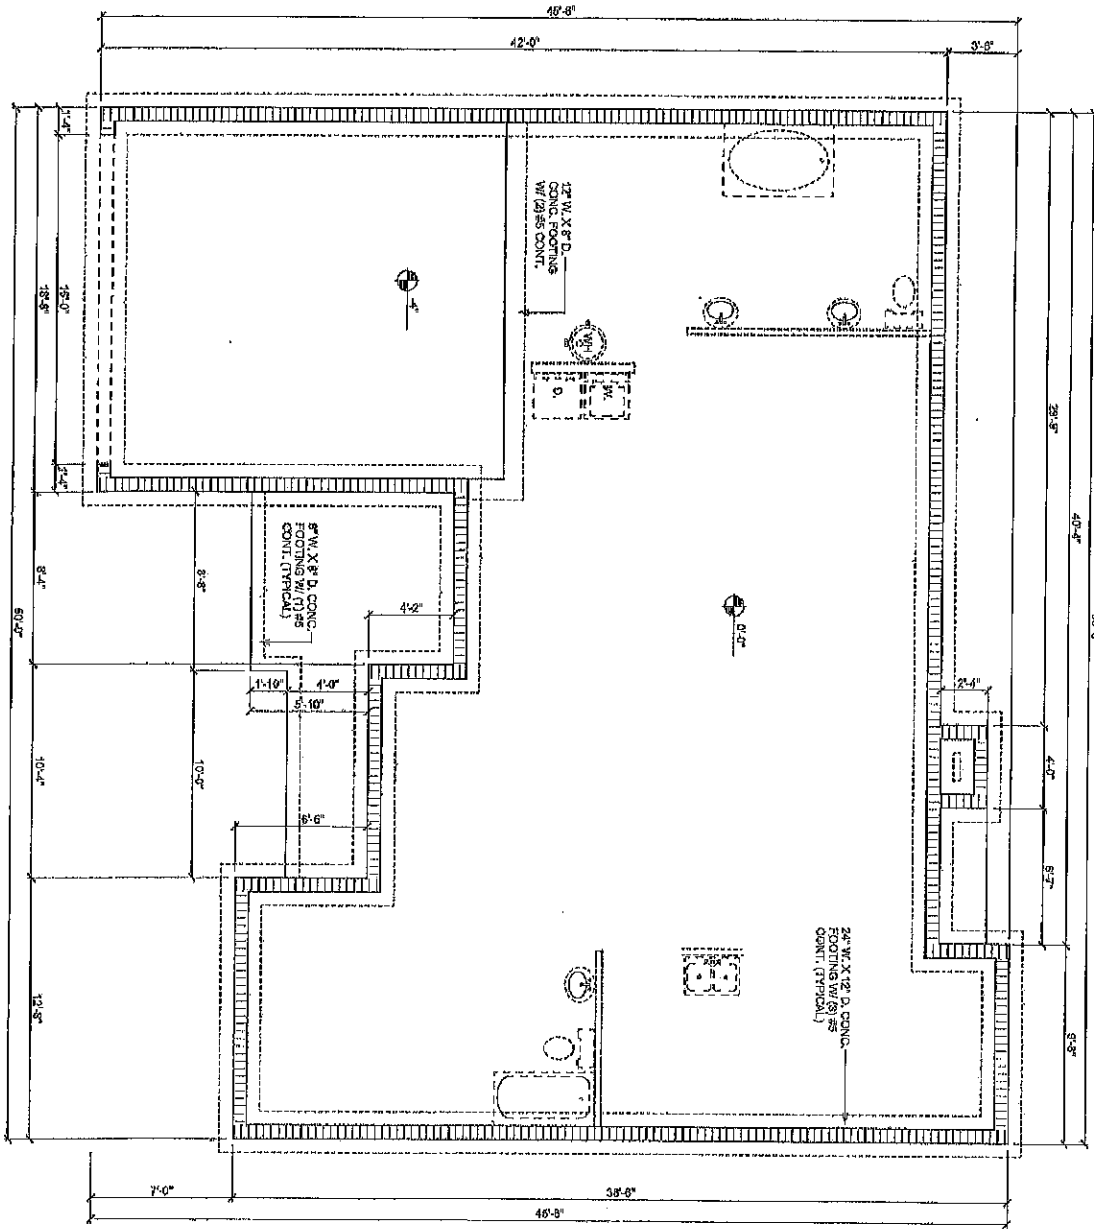

ROOF PLAN
SCALE: 3/4" = 1'-0"

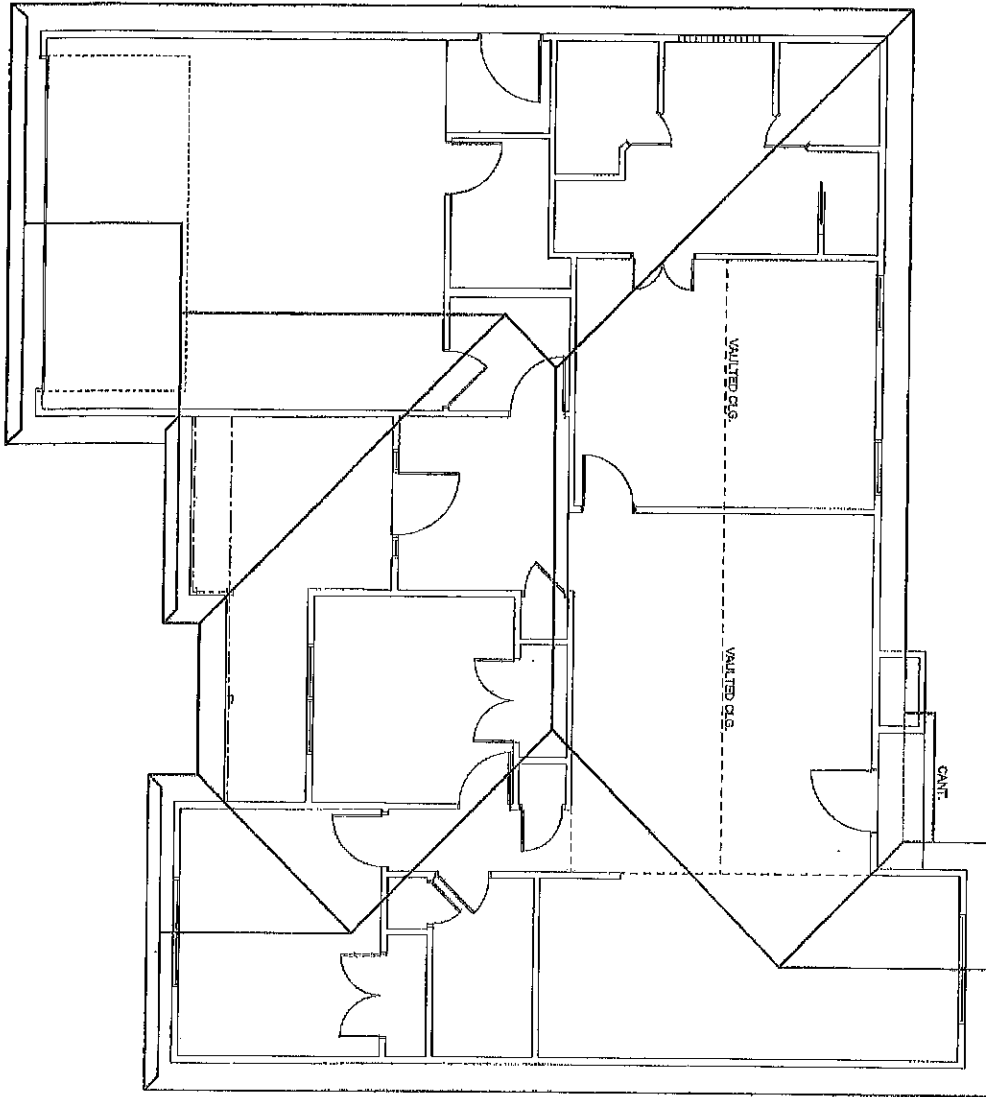

5 OF 5

PROJECT #1102
SHEET NUMBER

DATE: 08/01/2011
DRAWN: RD
CHECKED:
REVISIONS:


A PROPOSED RESIDENCE FOR:
WILLOW MODEL
LEFT HAND GARAGE

FIRST PRIORITY CONSTRUCTION
GREENVILLE, NC (252) 714-5891

VISUAL CONCEPTS
DRAWING & DESIGN
9529 840-7038

- NOTES:**
- UNLESS OTHERWISE NOTED
 1. ALL ELECTRICAL WORK IS INTENDED FOR BID PURPOSES ONLY. ALL WORK SHALL BE DONE IN STRICT ACCORDANCE WITH THE NATIONAL ELECTRIC CODE, LATEST EDITION. ALL UNUSED ELECTRICAL CONNECTIONS SHALL BE RESTRICED FROM THE PANEL WITH A SERIES OF ALL ELECTRICAL WORK IS RESPONSIBLE.
 2. SMOKING DETECTORS SHALL BE INSTALLED AS DIRECTED BY THE NEW 72 NATIONAL FIRE ALARMCODE.
 3. PROVIDE ARTS AND PAINT INTERPRETERS IN ALL DWELLING UNIT BEDROOMS PER NEC, SECTION 240.242.
 4. BATHROOM FANS TO BE VENTED THRU ROOF

ELECTRICAL LEGEND					
SYMBOL	DEFINITION	NOTES	SYMBOL	DEFINITION	NOTES
⊕	120V OUTLET		⊕	EXHAUST FAN WITH LIGHT	
⊕	120V OUTLET		⊕	FLUORESCENT RECIPE	
⊕	220V OUTLET		⊕	RECESS LIGHTING	
⊕	EXTERIOR WATERPROOF OUTLET		⊕	PHONE	
⊕	SWITCH		⊕	SMOKE DETECTOR	
⊕	CEILING FAN WITH LIGHT		⊕	AIR COND. DISCONNECT	
			⊕	METERS	
			⊕	BATT. BACKUP W/ HARDWARE CONNECTED	

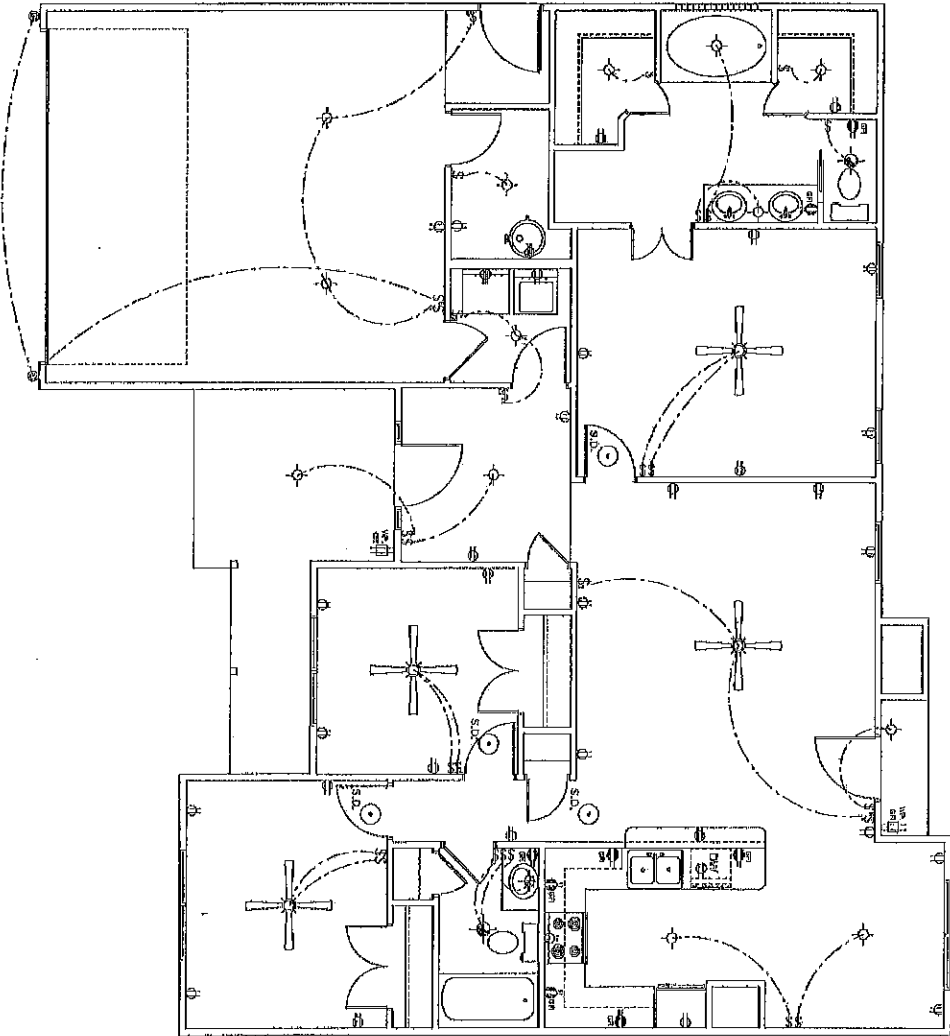

ELECTRICAL PLAN
SCALE: 1/8" = 1'-0"